
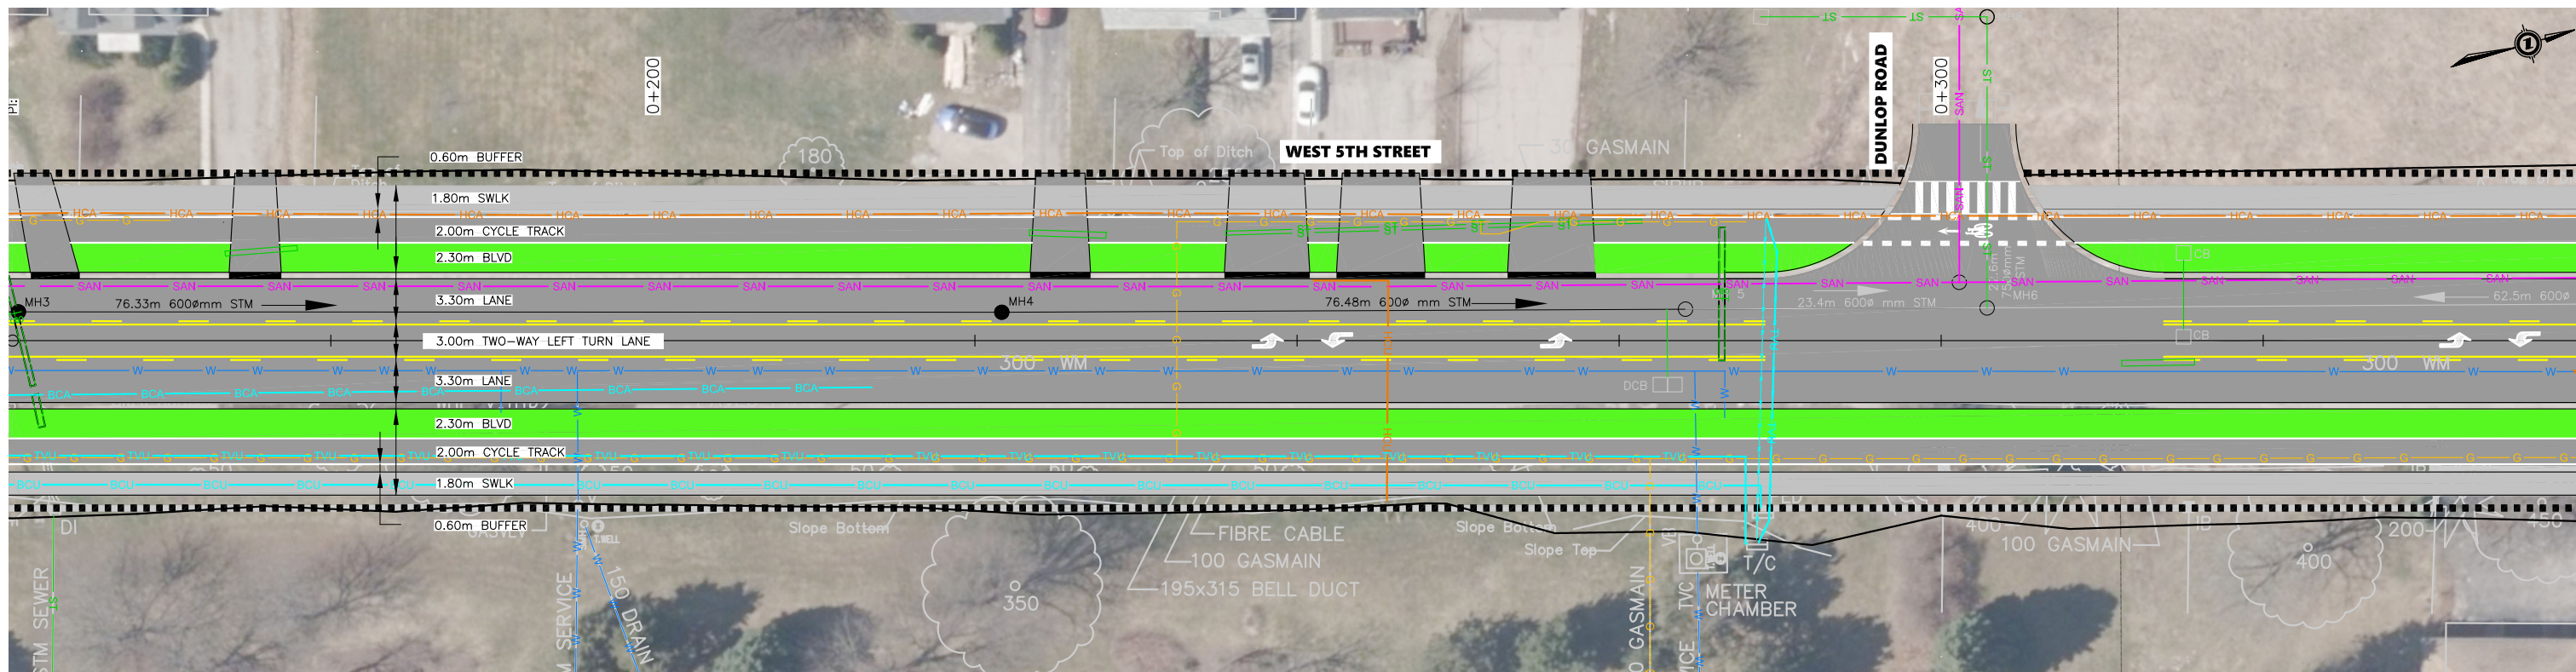


Appendix J:

Composite Utility Plan

SUPPLEMENTAL LEGEND:

- EXISTING R.O.W.
- PROPOSED 36m R.O.W.
- PROPOSED GRADING
- HYDRO UNDERGROUND
- COMMUNICATION UNDERGROUND
- COMMUNICATION AERIAL
- HYDRO AERIAL
- WATERMAIN
- STORM SEWER
- SANITARY SEWER
- BELL UNDERGROUND
- BELL AERIAL
- UNDERGROUND GAS
- PROPOSED ROADWAY/CYCLE TRACK
- PROPOSED SIDEWALK

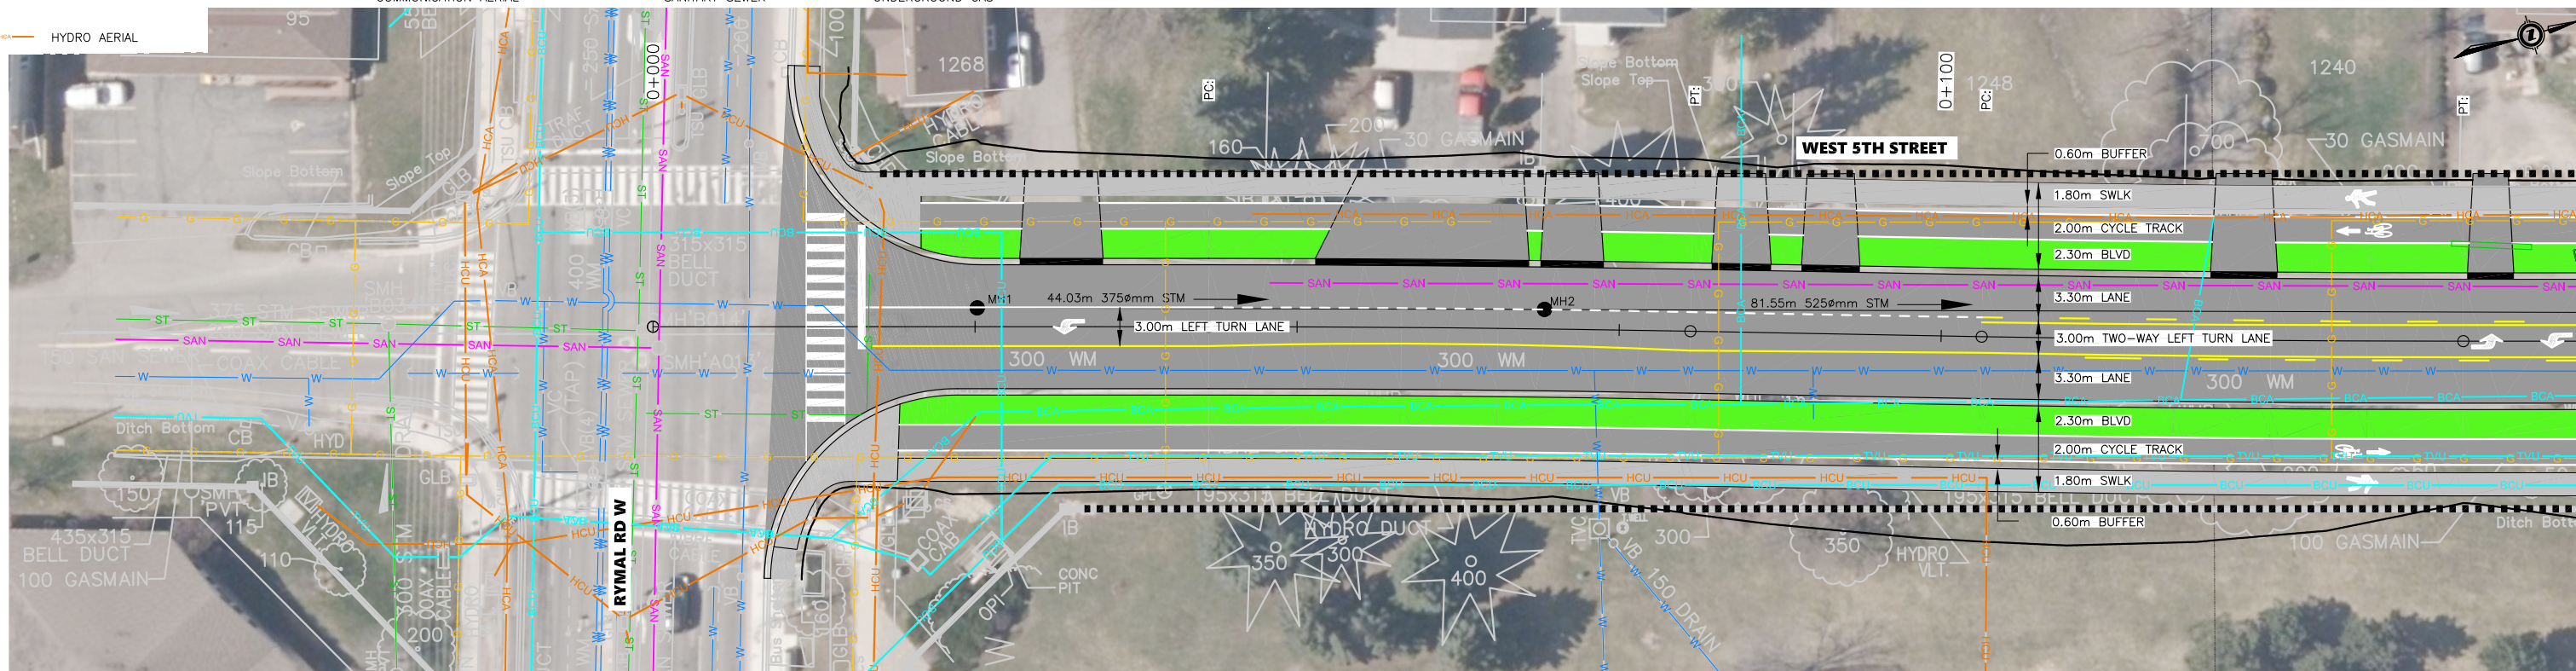

EXISTING SERVICES	DRAWING #, SOURCE	DATE	CONSTRUCTED SERVICES	COMPLETION	DETAILS	No.	REVISIONS	DATE	CONSULTANT
					DESIGN	MK			
					DRAWN BY	MK			
					CHECKED	IB			
					APPROVED	IB			
					DATE	AUGUST 2025			
						165001381			

CONSULTANT OR DIVISION





Stantec Consulting Ltd.
1305 Riverbend Road #400
London ON Canada
N6K 0J5
Tel. 519.645.2007
Fax. 519.645.6575
www.stantec.com

ENGINEER'S STAMP



SCALE	TITLE	PROJECT No.
	WEST 5TH STREET EA	
	WEST 5TH STREET COMPOSITE UTILITY PLAN	SHEET No. 01
		PLAN FILE No.

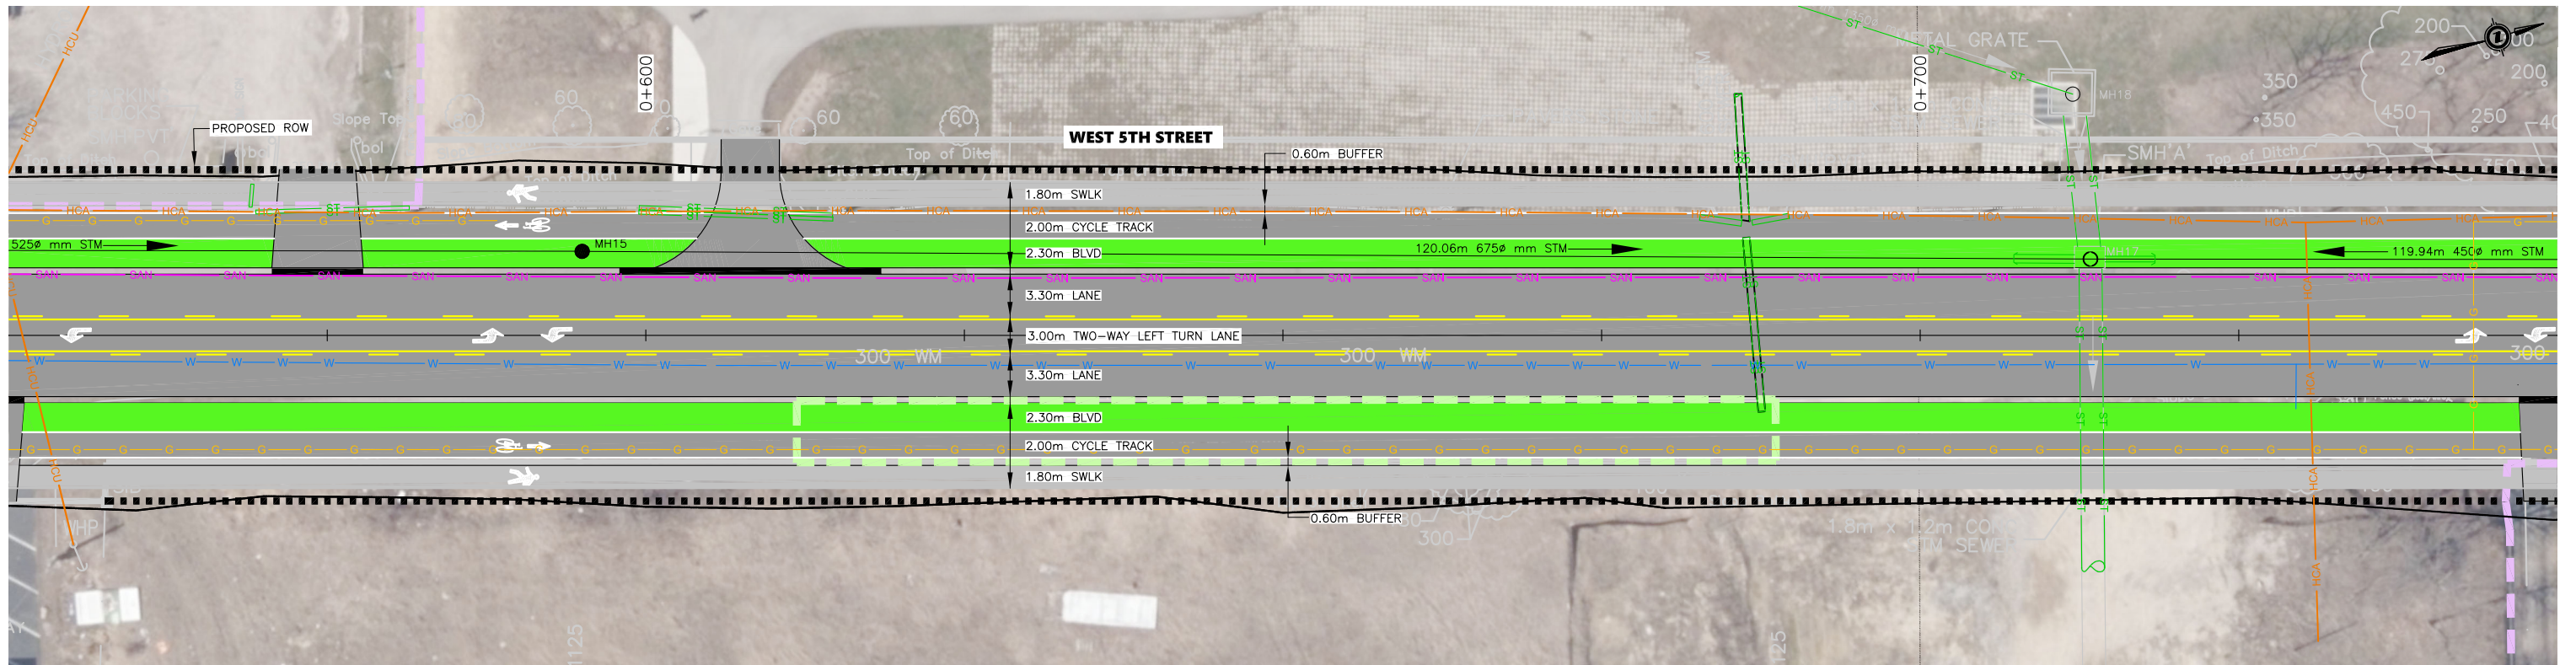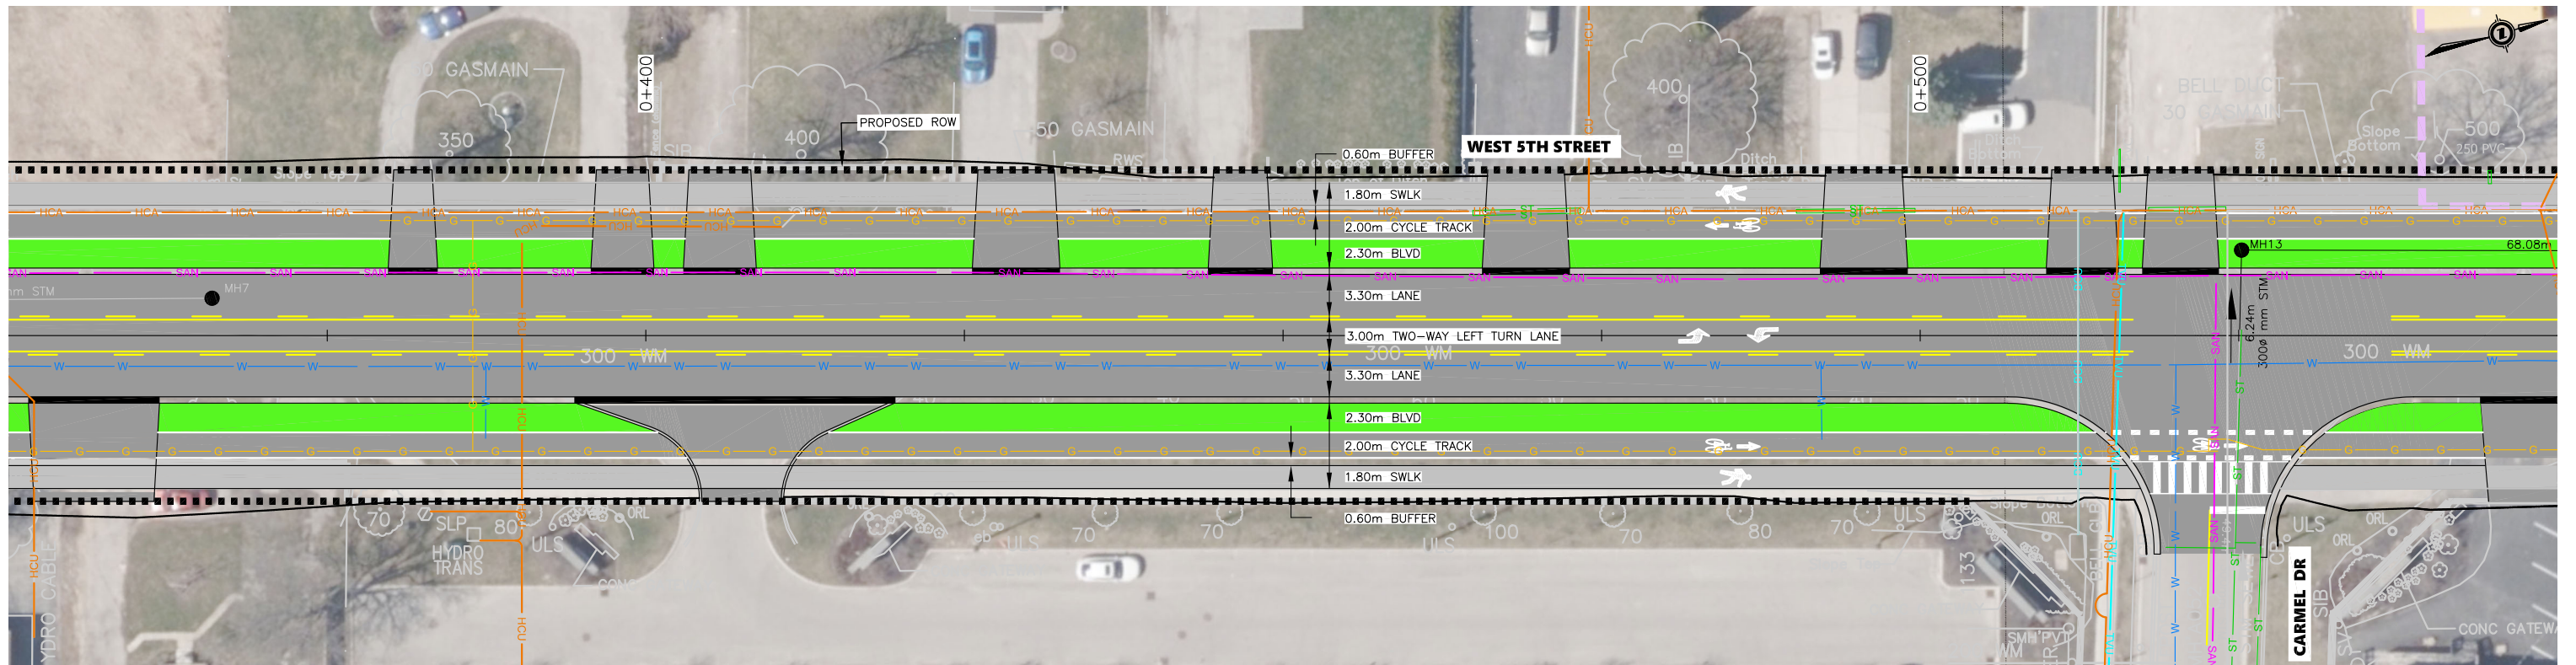

EXISTING SERVICES	DRAWING #, SOURCE	DATE	CONSTRUCTED SERVICES	COMPLETION	DETAILS	No.	REVISIONS	DATE	CONSULTANT
					DESIGN	MK			
					DRAWN BY	MK			
					CHECKED	IB			
					APPROVED	IB			
					DATE	AUGUST 2025			
						165001381			

CONSULTANT OR DIVISION



Stantec Consulting Ltd.
1305 Riverbend Road #400
London ON Canada
N6K 0J5
Tel. 519.645.2007
Fax. 519.645.6575
www.stantec.com

ENGINEER'S STAMP



SCALE

TITLE

WEST 5TH STREET EA



WEST 5TH STREET
COMPOSITE UTILITY PLAN

PROJECT No.

SHEET No.

02

PLAN FILE No.

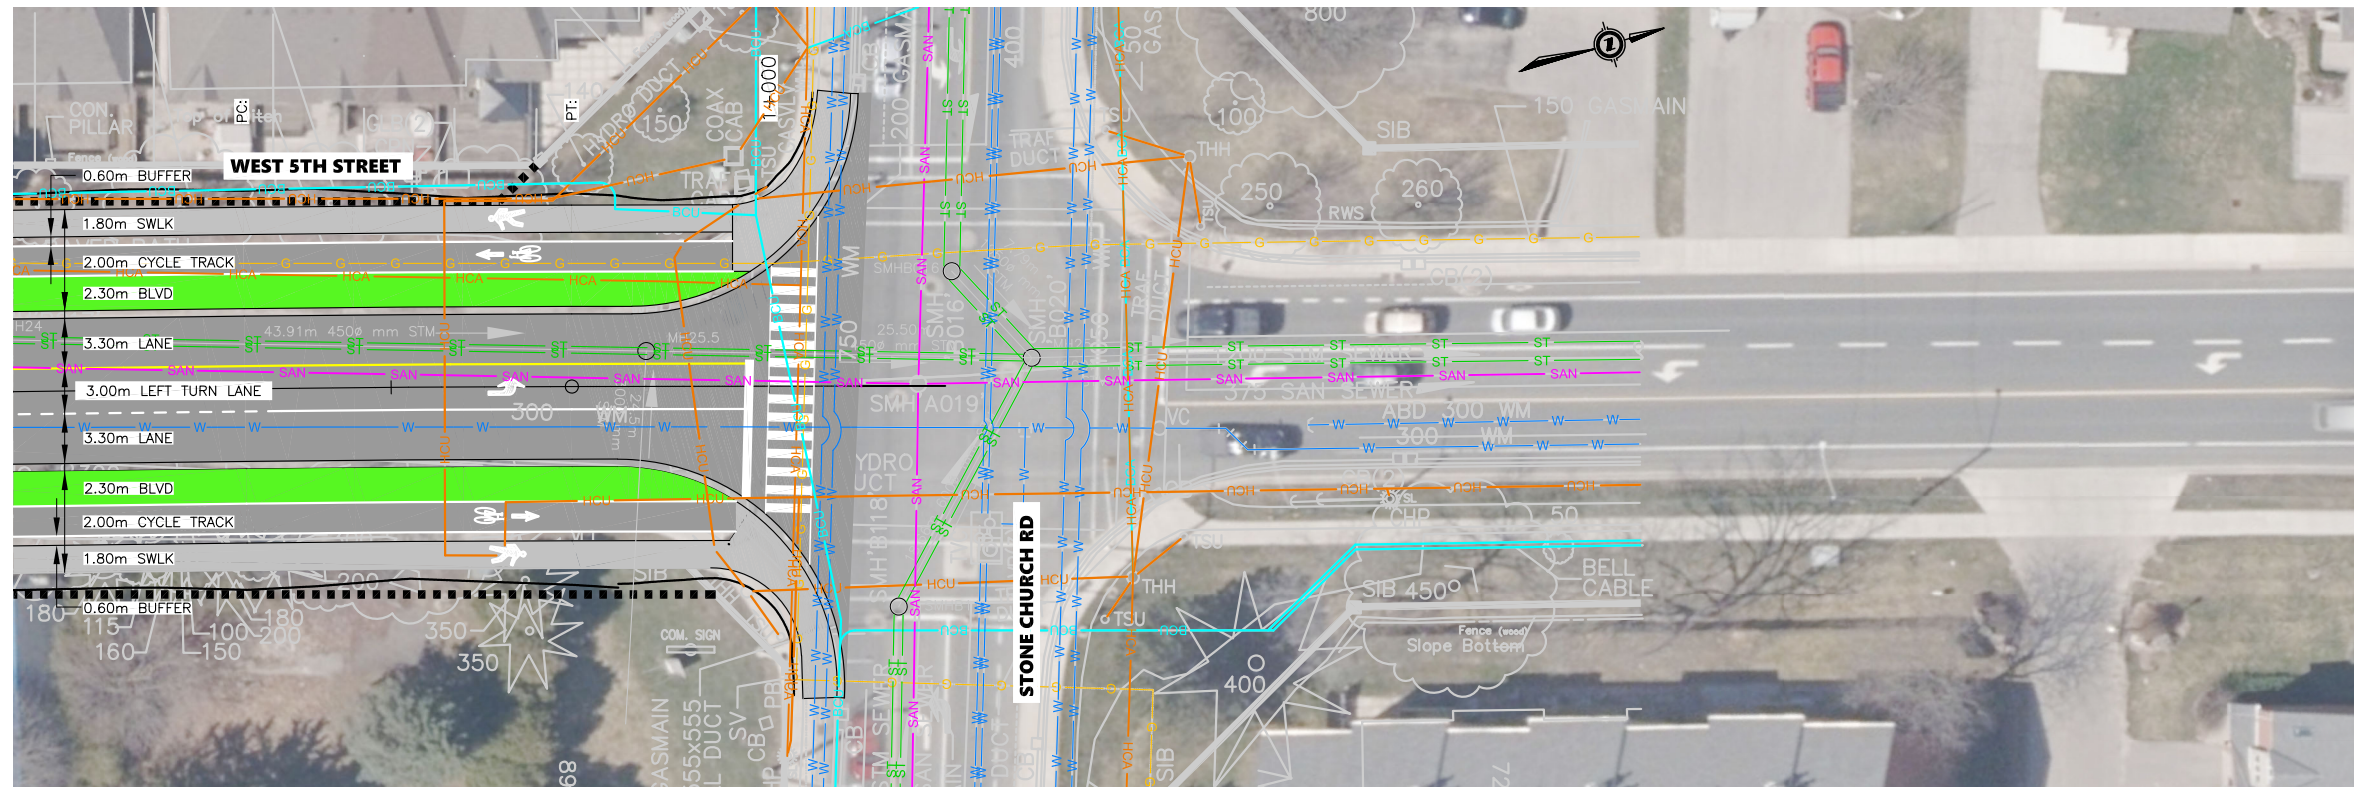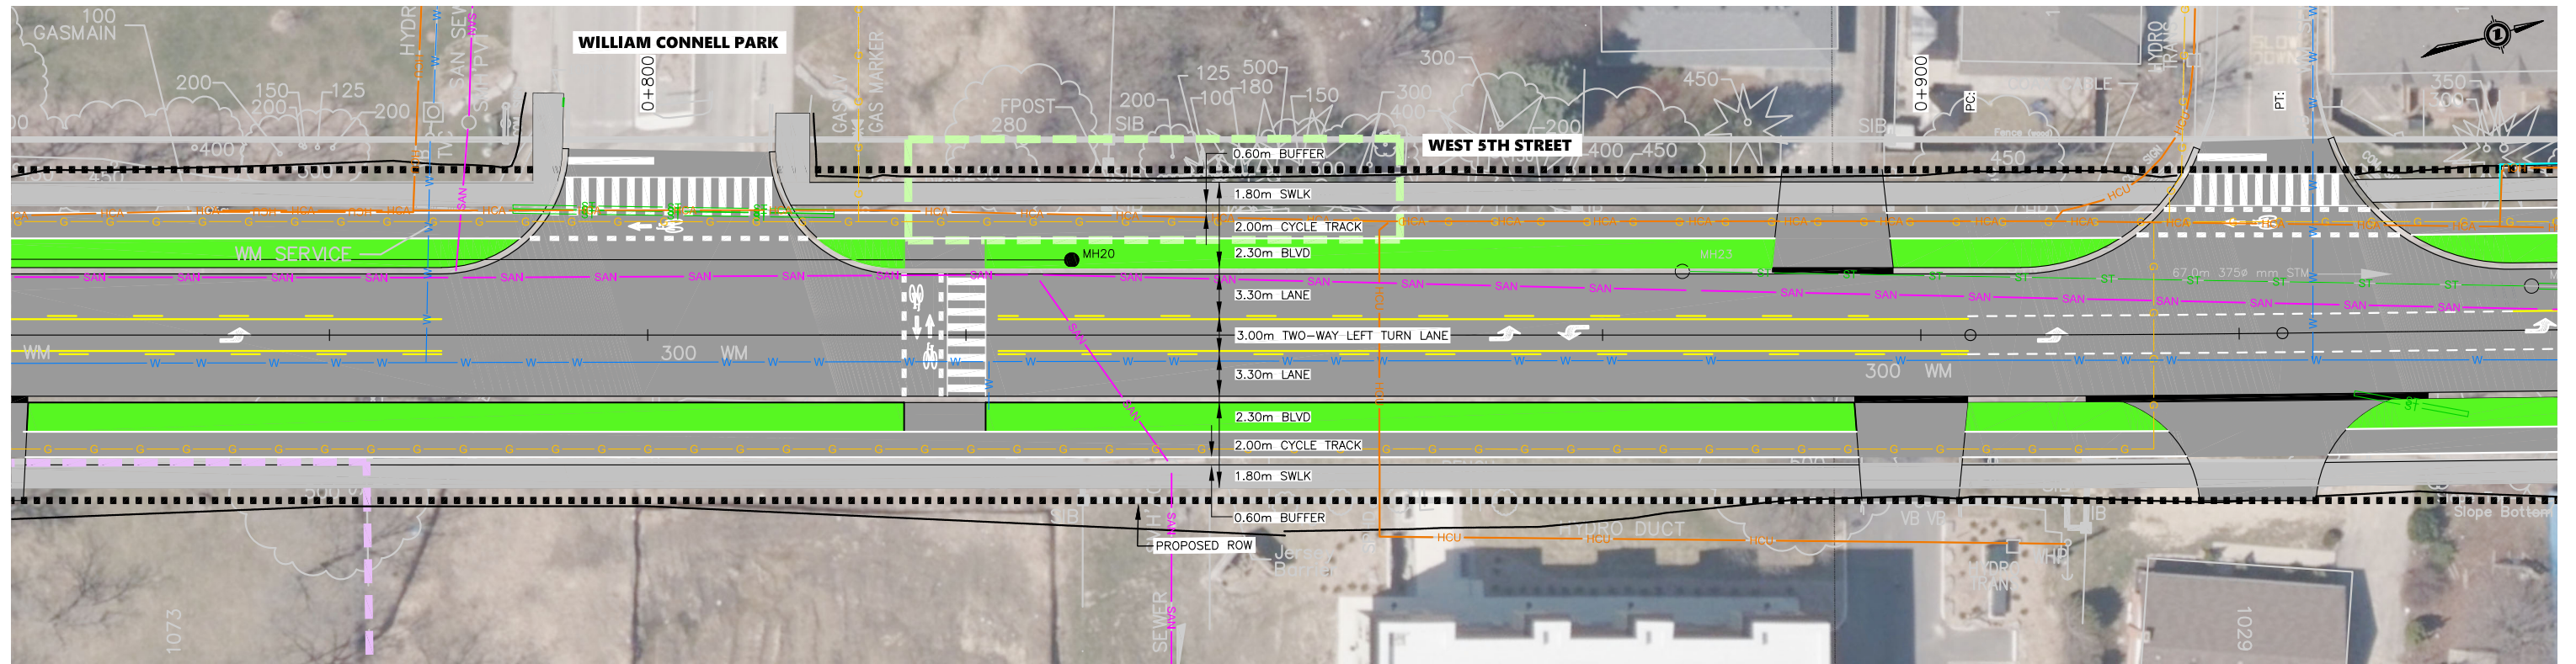

EXISTING SERVICES	DRAWING #, SOURCE	DATE	CONSTRUCTED SERVICES	COMPLETION	DETAILS	No.	REVISIONS	DATE	CONSULTANT
					DESIGN	MK			
					DRAWN BY	MK			
					CHECKED	IB			
					APPROVED	IB			
					DATE	AUGUST 2025			
						165001381			

CONSULTANT OR DIVISION



Stantec Consulting Ltd.
1305 Riverbend Road #400
London ON Canada
N6K 0J5
Tel. 519.645.2007
Fax. 519.645.6575
www.stantec.com

ENGINEER'S STAMP



SCALE

TITLE

WEST 5TH STREET EA

WEST 5TH STREET
COMPOSITE UTILITY PLAN

PROJECT No.



SHEET No.

03

PLAN FILE No.

SUPPLEMENTAL LEGEND:

- EXISTING R.O.W.
- PROPOSED 36m R.O.W.
- PROPOSED GRADING
- HYDRO AERIAL
- HYDRO UNDERGROUND
- COMMUNICATION UNDERGROUND
- COMMUNICATION AERIAL
- WATERMAIN
- STORM SEWER
- SANITARY SEWER
- BELL UNDERGROUND
- BELL AERIAL
- UNDERGROUND GAS
- POTENTIAL CONFLICT
- PROPOSED ROADWAY/CYCLE TRACK
- PROPOSED SIDEWALK

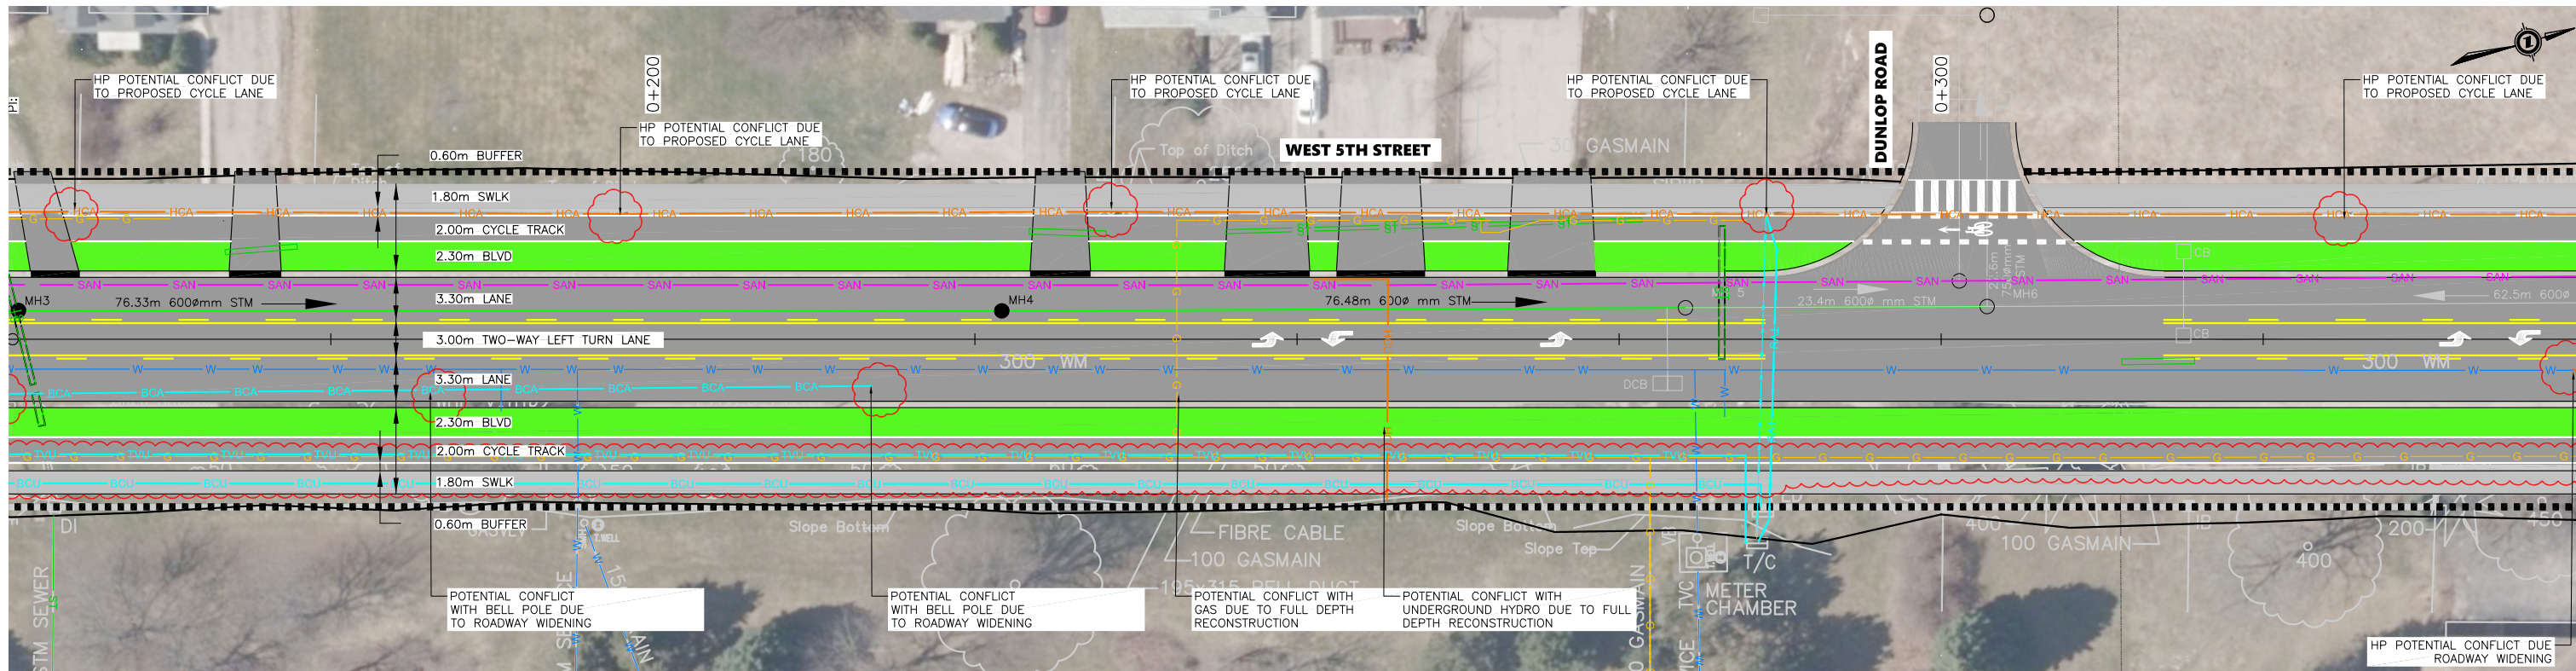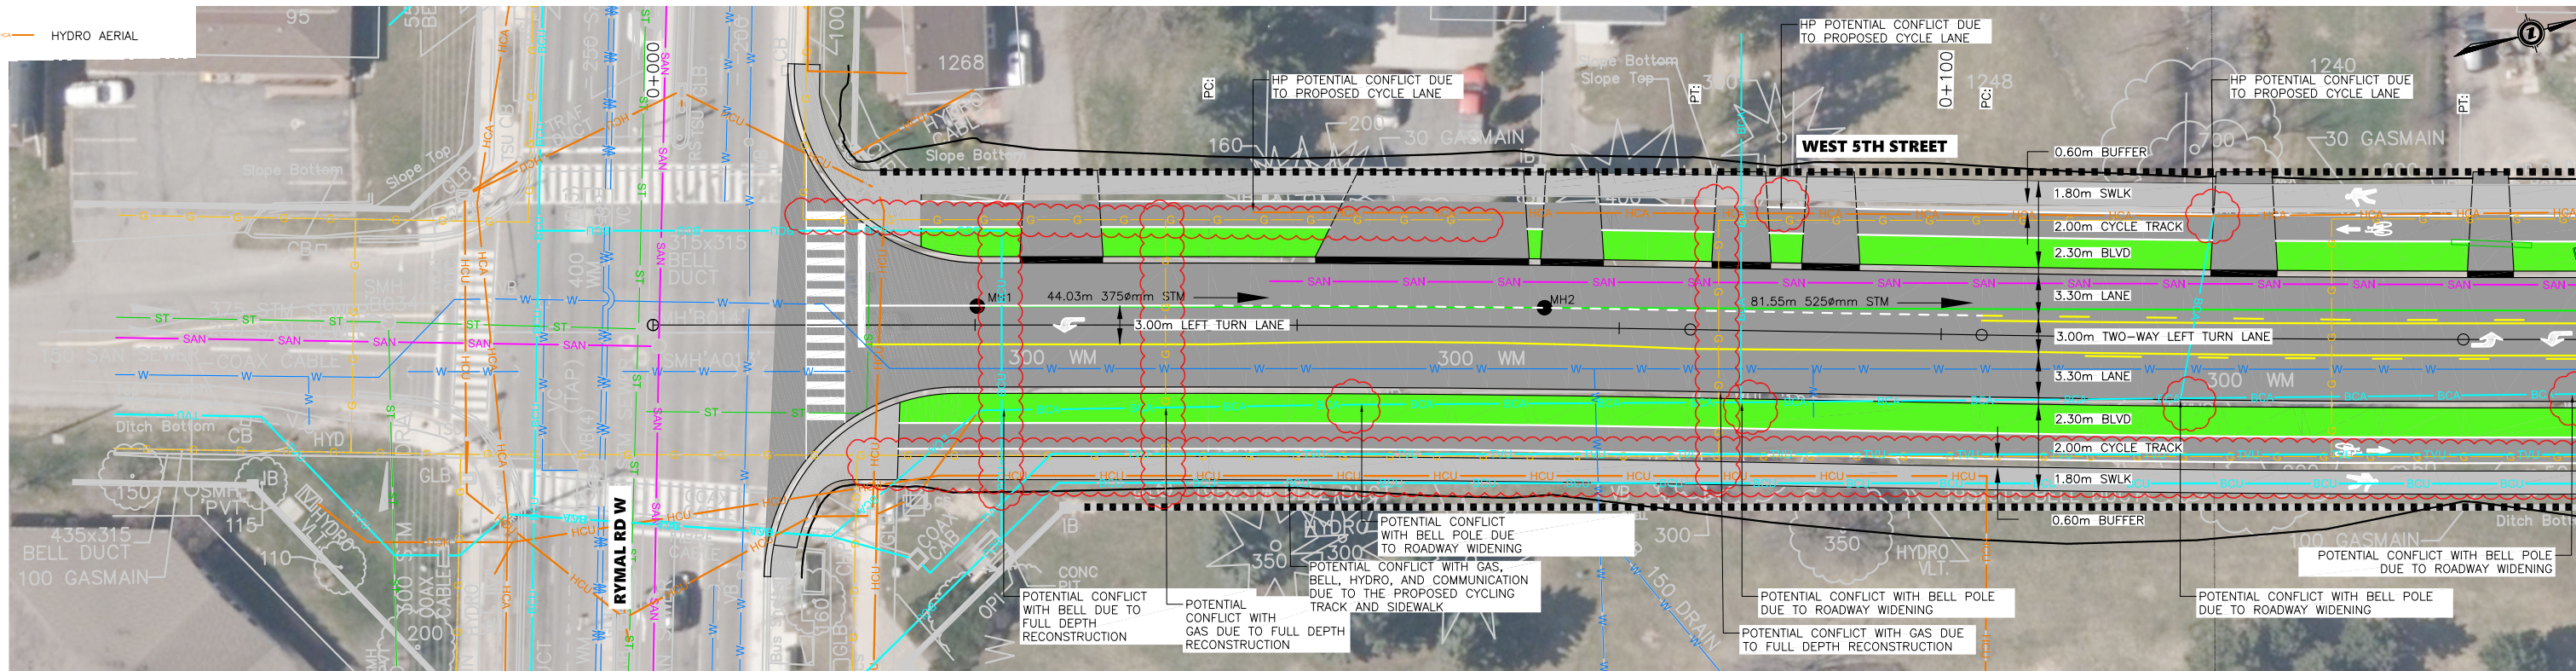

EXISTING SERVICES	DRAWING #, SOURCE	DATE	CONSTRUCTED SERVICES	COMPLETION	DETAILS	No.	REVISIONS	DATE	CONSULTANT
					DESIGN	MK			
					DRAWN BY	MK			
					CHECKED	DE			
					APPROVED	IB			
					DATE	AUGUST 2025			
						165001381			

CONSULTANT OR DIVISION

Stantec Consulting Ltd.
1305 Riverbend Road #400
London ON Canada
N6K 0J5
Tel. 519.645.2007
Fax. 519.645.6575
www.stantec.com

ENGINEER'S STAMP

Hamilton

SCALE

TITLE

WEST 5TH STREET EA



WEST 5TH STREET
UTILITY CONFLICT PLAN

PROJECT No.

SHEET No.

01

PLAN FILE No.

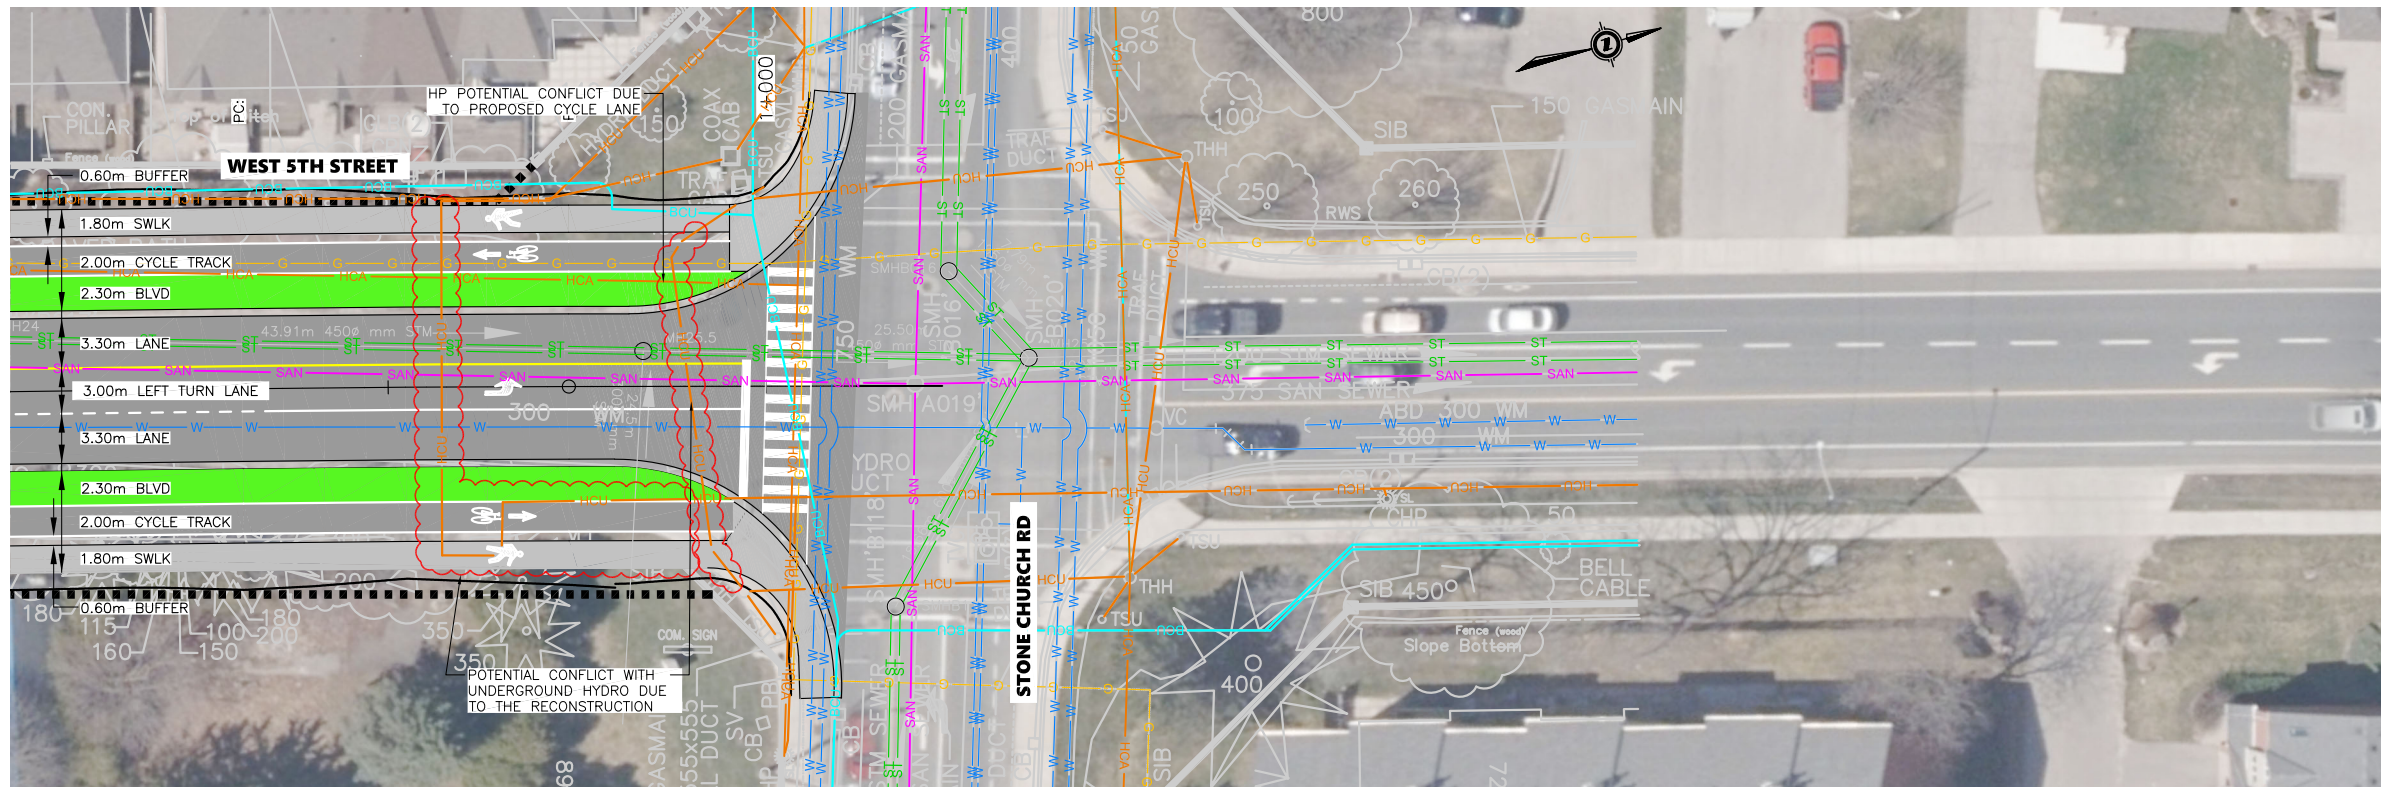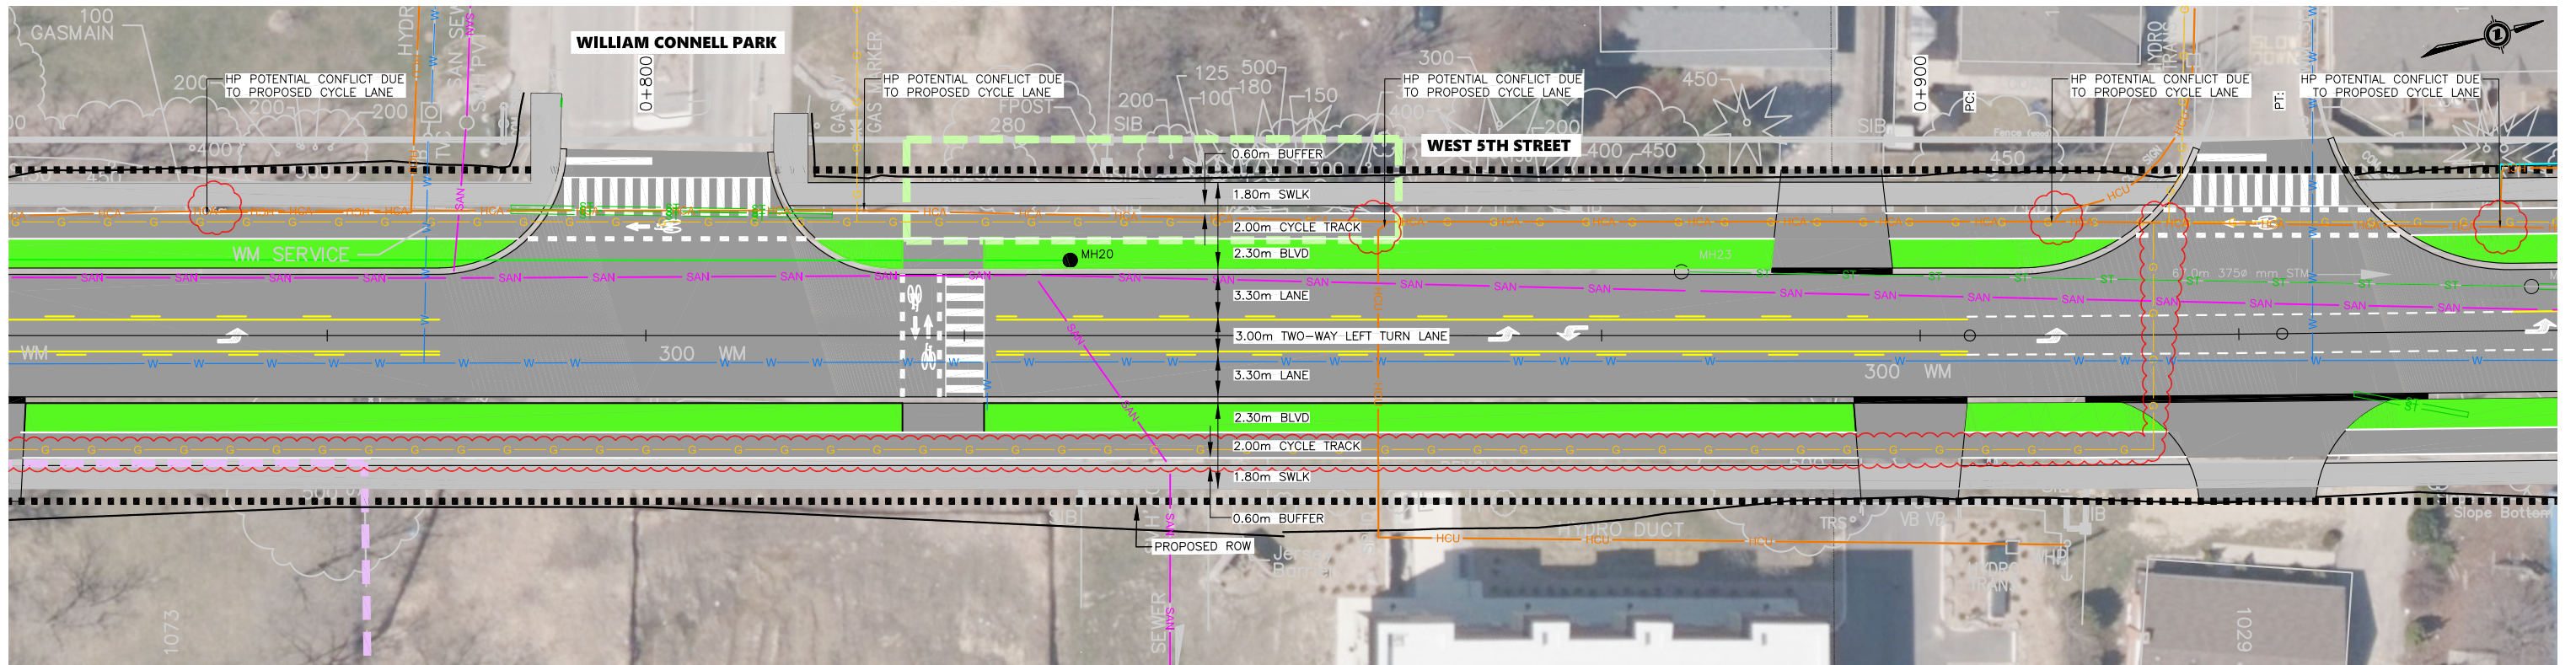


EXISTING SERVICES	DRAWING #, SOURCE	DATE	CONSTRUCTED SERVICES	COMPLETION	DETAILS	No.	REVISIONS	DATE	CONSULTANT
		11/20/22			DESIGN	MK			
					DRAWN BY	MK			
					CHECKED	DE			
					APPROVED	IB			
					DATE	AUGUST 2025			
						165001381			

CONSULTANT OR DIVISION

Stantec Consulting Ltd.
1305 Riverbend Road #400
London ON Canada
N6K 0J5
Tel. 519.645.2007
Fax. 519.645.6575
www.stantec.com

ENGINEER'S STAMP

Hamilton

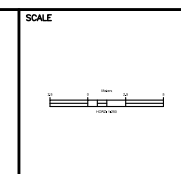

TITLE

WEST 5TH STREET EA

WEST 5TH STREET
UTILITY CONFLICT PLAN

PROJECT No.	
SHEET No.	03
PLAN FILE No.	